
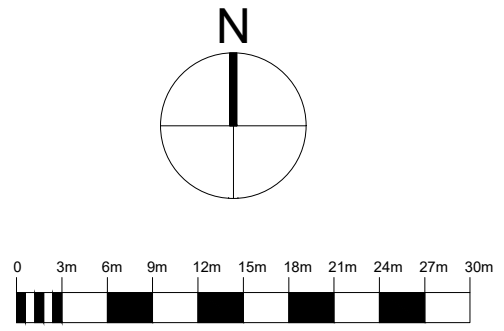


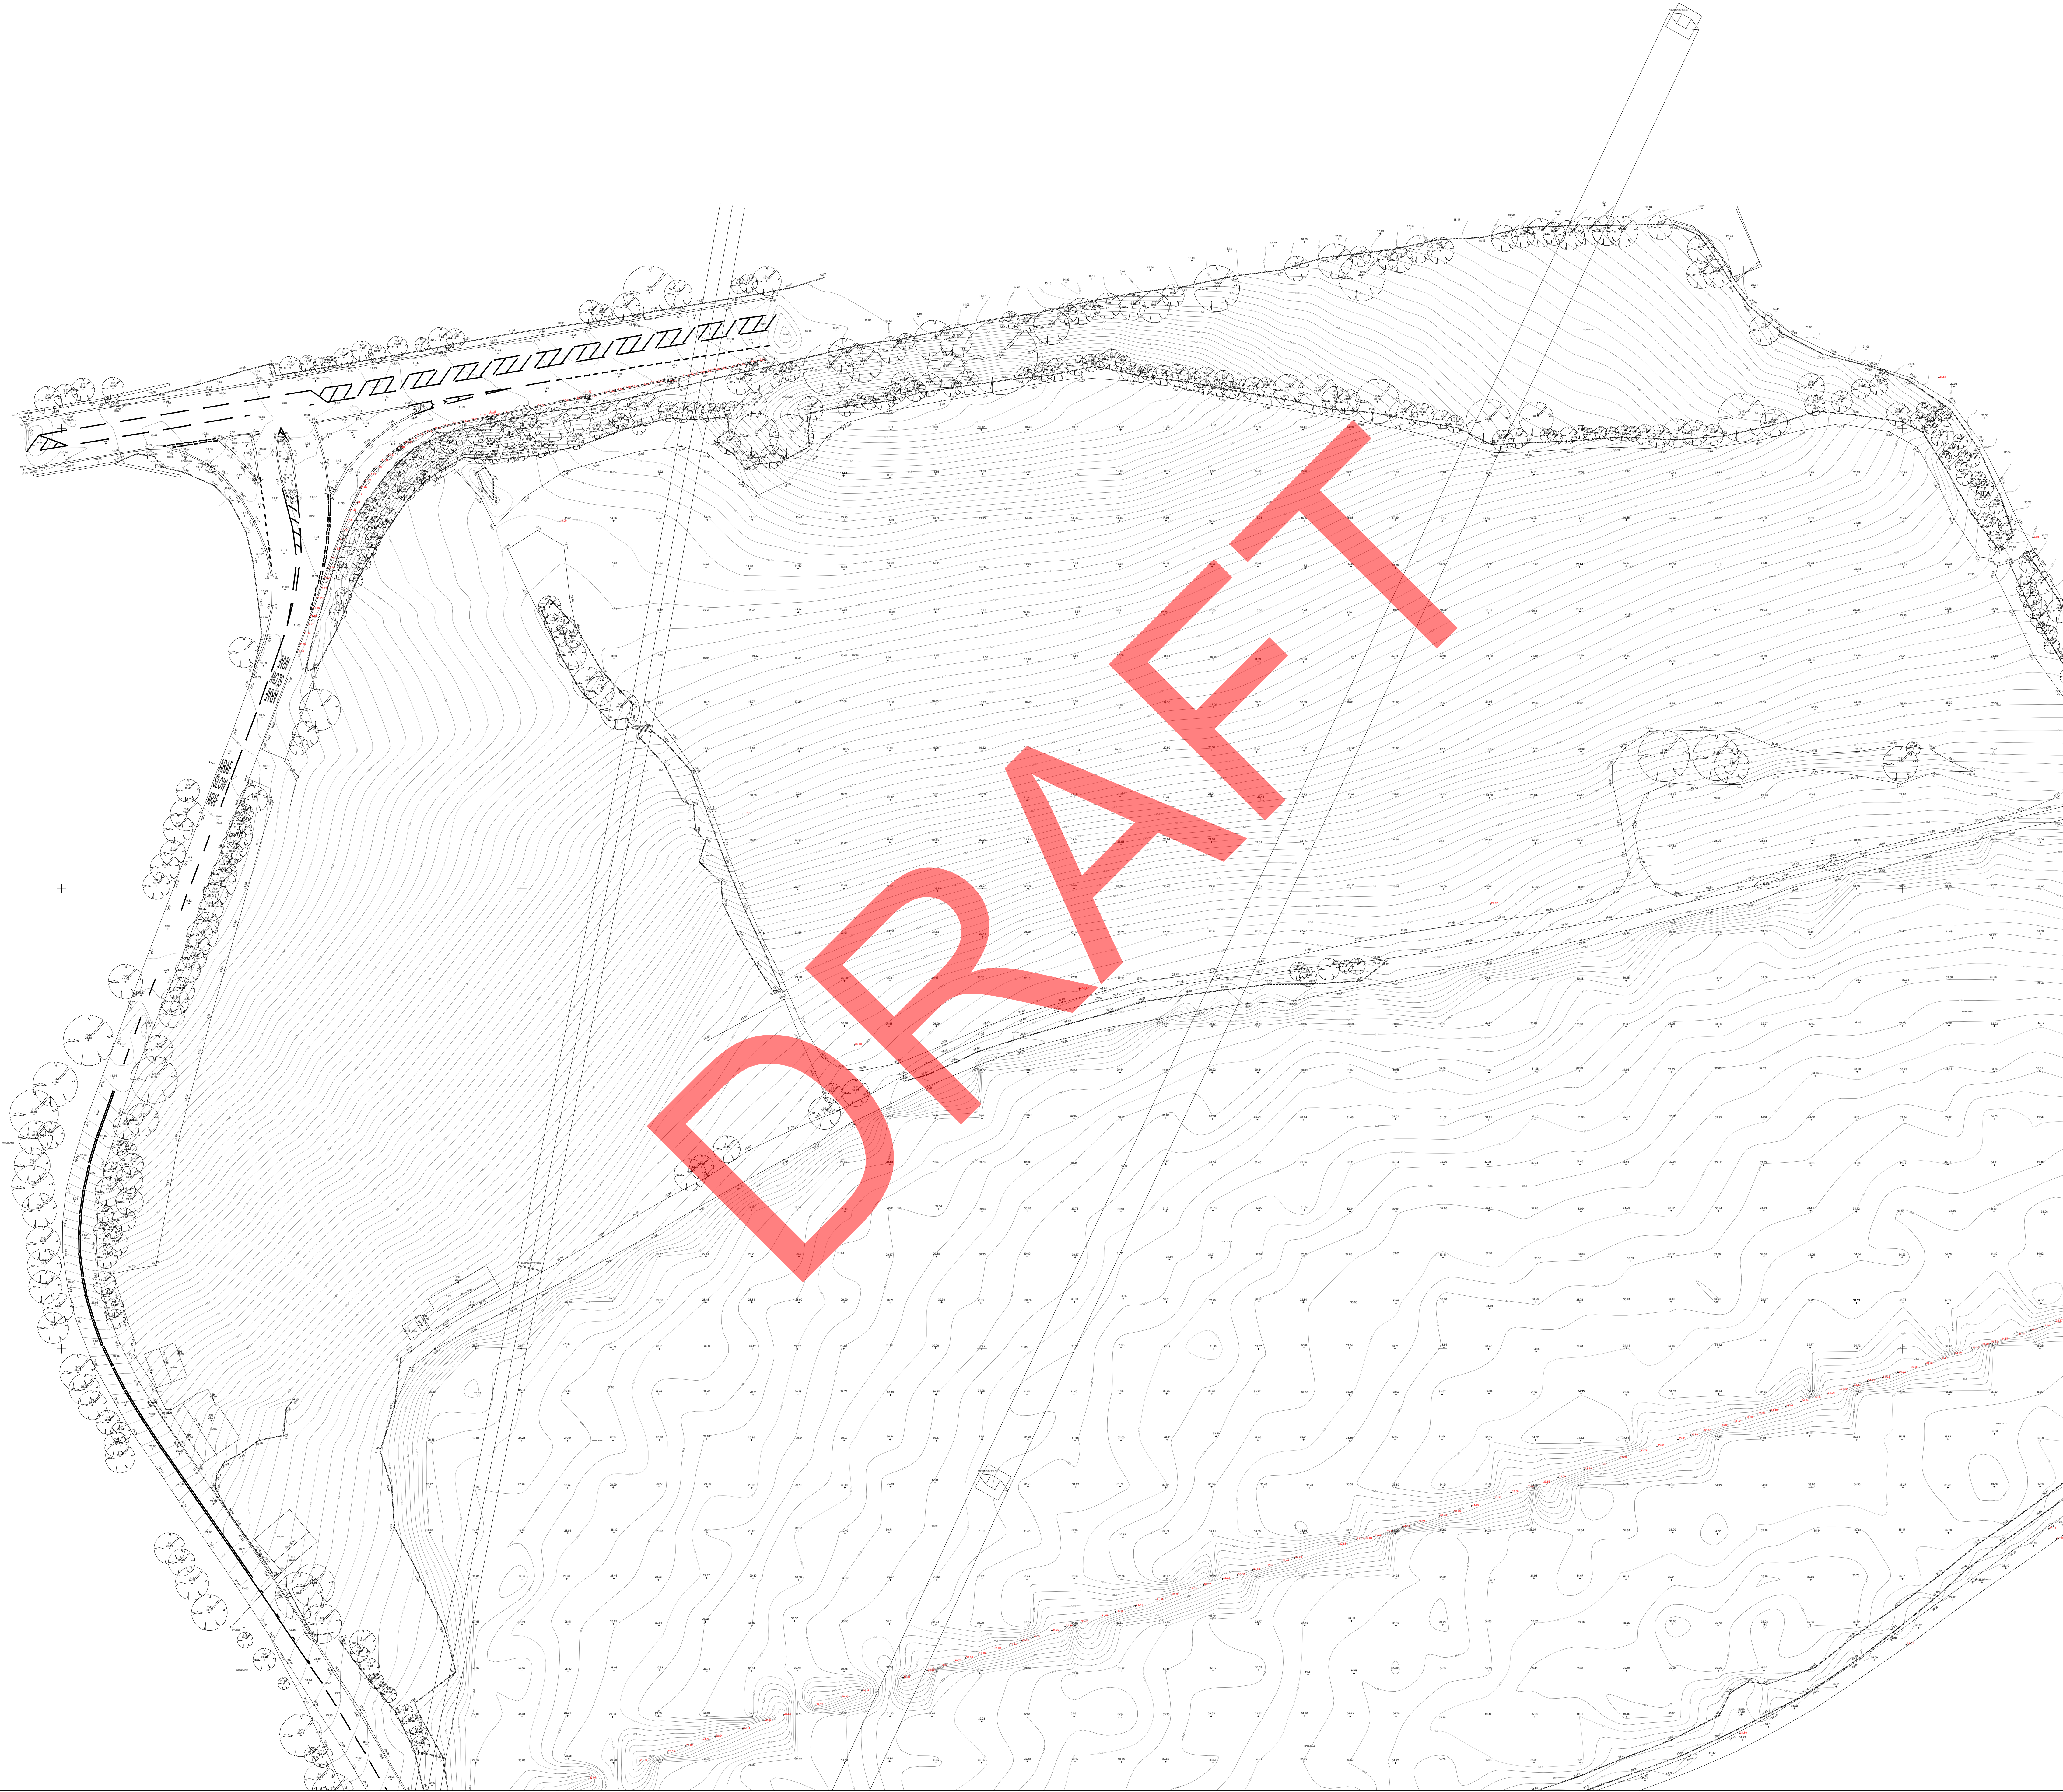

Notes :

Station	Easting	Northing	Level
---------	---------	----------	-------

ON DETAIL SURVEY

AB	Air Brick	EP	Electricity Pole	RWOP	Rain Water Pipe
AC	Asbestos Cement	ER	Earth Rod	S	Stump
ACU	Air Conditioning Unit	FB	Flower Bed	SAG	O/H Cable Sag Height
AD	Assumed Direction	FD	Fire Hydrant	S/A	Soilaway
AL	Air Line	FL	Floor Level	SC	Stop Cock
AR	Assumed Route	FS	Flag Staff	S	Slope Iron
ASP	Artificial Stone Paving	G	Gully	SL	Soil Level
AT	Air Tower	H	Height	SLV	Sluice Valve
AV	Air Valve	IC	Inspection Cover	SP	Sign Post
BB	Bellish Beacon	IL	Invert Level	Spr	Spring
BD	Back Drop	JB	Junction Box	SS	Structure Support
BL	Bed Level	KO	Kerf Outlet	ST	Stop Tap
BH	Borehole	LB	Letter Box	STN	Survey Control Station
BL	Brick	LI	Light	SV	Stop Valve
BL	Building Point	LP	Lamp Post	SVP	Soil Vent Pipe
BOL	Boloid	NB	Multiple Bolt	Tac	Tactile Paving
BS	Bus Stop	MH	Manhole Cover	TBM	Temporary Bench Mark
BT	British Telecom Box	NOP	Marker Post	TCH	Telephone Call Box
BTB	British Telecom Box	MP	Mile Post / Stone	T/H	Top Of Hedge
CAB	Cabinet	NM	Node Marker	T/V	Top Of Vegetation
Cam	Camera	NP	Name Plate	T/P	Top Of Parapet Level
CAT	Catenary Level	NPV	No Pipes Visible	T/T	Threshold Level
CC	Control Cabinet	OSA	Overhead	T/T	Tree Top
CH	Channel	OSV	Off Survey Area	T/W	Top Of Fence
CH	Channel Level	PO	Post	T/W	Top Of Wall
CL	Cast Iron	PB	Post Box	TS	Traffic Signal
CL	Cast Level	PM	Permanent Bench Mark	UTGA	Unable to Gain Access
CP	Concrete	PGM	Permanent Ground Marker	UTL	Unable to Lift
CP	Concrete	PLA	Plastic	UTS	Unable to Survey
CPS	Concrete Paving Slabs	PM	Parking Meter	VC	Verified Clay
CTV	Cable TV	PST	Say Wire Anchor Point	VDP	Vehicle Detector Pads
CU	Culvert	PT	Polythene Tunnel	VP	Vent Pipe
D	Depth (deep)	PTH	Principal Tree Height	VR	Vapour Recovery
DI	Ductile Iron	PJ	Pump	VTP	Vertical Pipes
dl	Dilapidated	RE	Rodding Eye	WL	Water Level
dl	Disused	R	Riser	WM	Water Meter
D/S	Downstream	RFL	Roof Level	WD	Water Wash Out
EB	Electric Box	RP	Reflector Post	WS	Window Sample
EIC	Electricity Inspection Cover	RS	Road Sign	WV	Water Valve

ON FENCES/WALLS/DIVISIONS

B/W	Barbed Wire Fence	FTR	Trellis Fence	S/F	Safety Fence
C/B	Crash Barrier	H/R	Hand Rail	S/R	Steel Railings
C/B	Close Boarded Fence	I/R	Iron Rail Fence	WM	Wire Mesh Fence
C/I	Corrugated Iron Fence	P/F	Picket Fence	BW	Brick Wall
CL	Chain Link Fence	P/L	Palisade Fence	OW	Concrete Wall
L/F	Electric Fence	P/R	Post and Rail Fence	D/W	Dry Stone Wall
P/B	Panel / Board Fence	P/W	Post and Wire Fence	R/W	Retaining Wall
				SW	Stone Wall

ON BUILDINGS

ASB	Asbestos	FRL	Flat Roof Level	SCH	Suspended Ceiling Height
AV	Air Vent	GRL	Glassed Roof Light	SCF	U/S Soffit Height
CH	Ceil Height	HL	Head Level	SOIL	Soil Pipe
CH	Ceil Height	PART	Partitioning	SVP	Sewer Vent Pipe
CHM	Chimney Stack Height	PL	Parapet Level	THL	Threshold Level
CH	Door Head	RL	Ridge Level	ULB	Underside Of Beam
DP	Down Pipe	RWC	Rain Water Channel	WH	Water Heater
EL	Eave Level	RWP	Rain Water Pipe	WP	Water Pipe
F	Frame Height	SA	Spring Of Arch	WST	Water Storage Tank

Rev:

Comments

By

Chkd

Date

Project Name
Castle Road BESS

File Name:
MBS-5731_Fonmon_TOPO

Drawing Title :
SITE PLAN (1 of 2)

Client:

Date
02/09/24

Scale
A0 @ 1:500

Drawn by:
TW

Checked by:
OW

Project Code:
MBS-5731

Revision:

Grid Orientation:
NORTH GPS

Site Level Datum
OS GPS

All dimensions are to be checked on site where applicable. This drawing must not be scaled, and only written dimensions should be respected.

Tree species and sizes on this drawing are not guaranteed, and if critical should be verified by an arboriculturist. Tree spreads are average about the bole, and heights are approximate at the time of the survey.

